




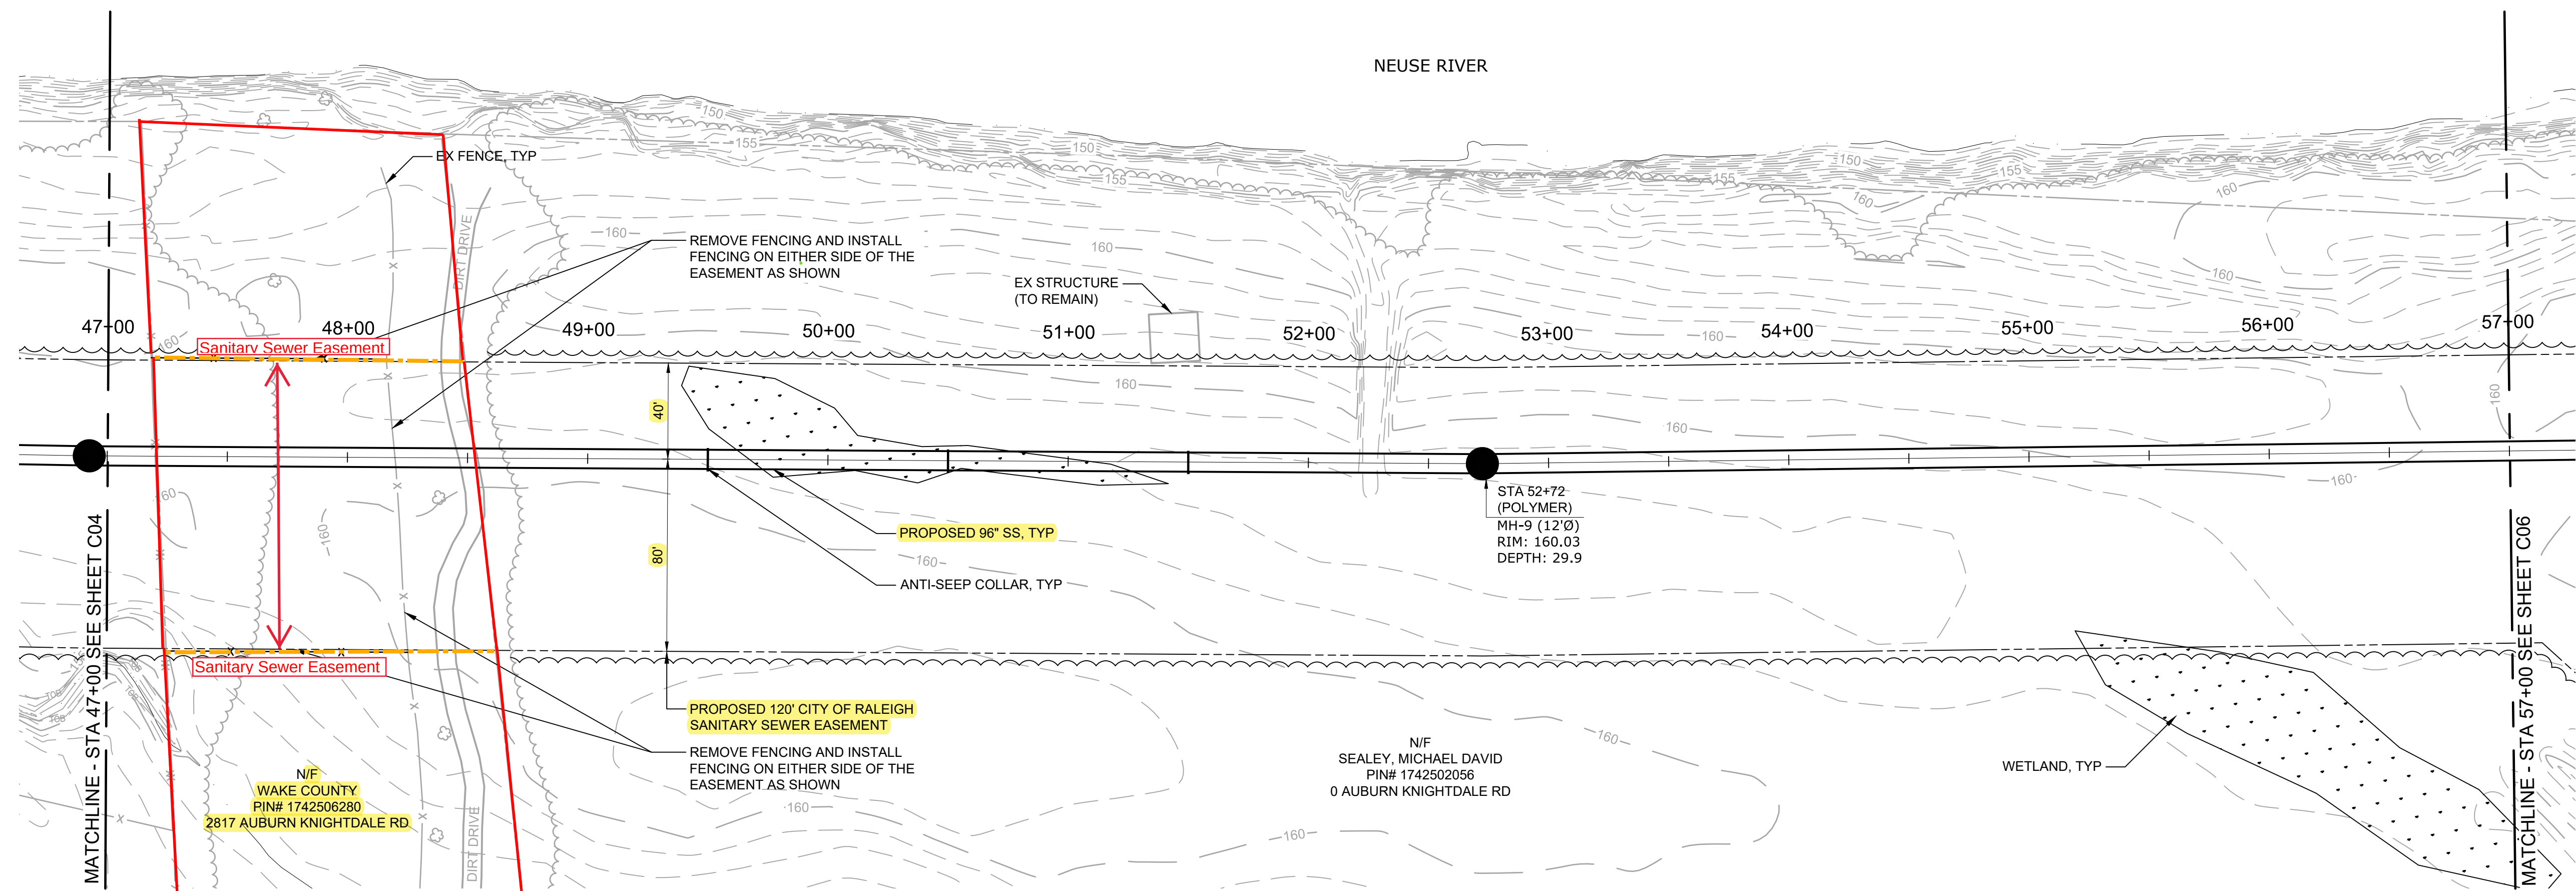

PLAN
SCALE: 1" = 40'

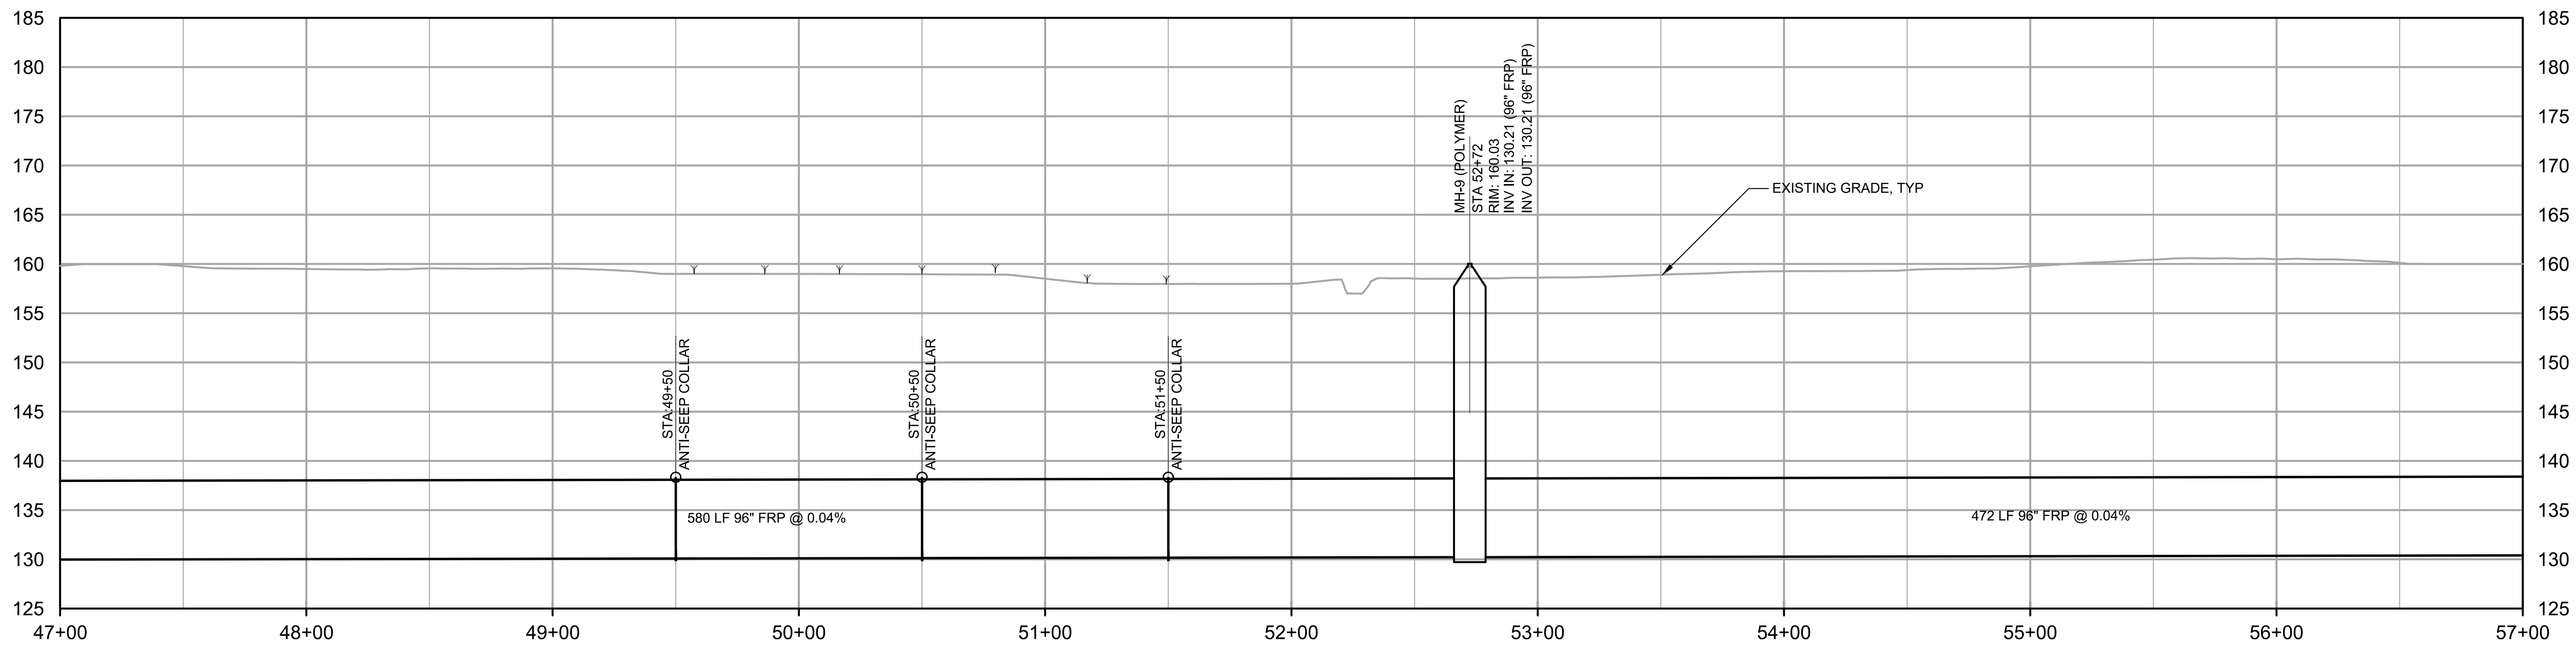

PROFILE
HORIZONTAL SCALE: 1" = 40'
VERTICAL SCALE: 1"=4'

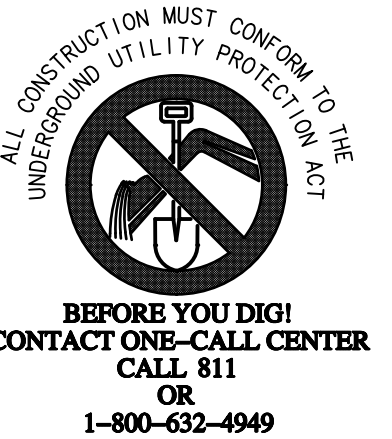

PLOT DATE: 10/16/2018 12:21:26 PM BY: ENE
FILE C:\Users\jwheeler\OneDrive\Documents\96" Interceptor\96" Interceptor.dwg Saved By: PSEIDGREG See Date: 2018/10/04 1:02 PM

REV	ISSUED FOR	DATE	BY

PROJECT ENGINEER:	T. TANT
DESIGNED BY:	S. LEITCH
DRAWN BY:	E. NG
CHECKED BY:	###
IF THIS BAR DOES NOT MEASURE 1" THEN DRAWING IS NOT TO FULL SCALE	0 1/2" 1"

60% DESIGN SUBMITTAL

Hazen
HAZEN AND SAWYER
4011 WESTCHASE BOULEVARD, SUITE 500
RALEIGH, NORTH CAROLINA 27607
LICENSE NO. : C-0381

CJS
Conveyance, PLLC
320 S. ACADEMY STREET
CARY, NC 27511
P-1611

CITY OF RALEIGH
PUBLIC UTILITIES DEPARTMENT

NEUSE RIVER EAST
PARALLEL INTERCEPTOR

96" INTERCEPTOR

PLAN AND PROFILE

STATION 47+00 TO 57+00

DATE:	OCTOBER 2018
HAZEN NO.:	32426-000
CONTRACT NO.:	1
DRAWING NUMBER:	C05