

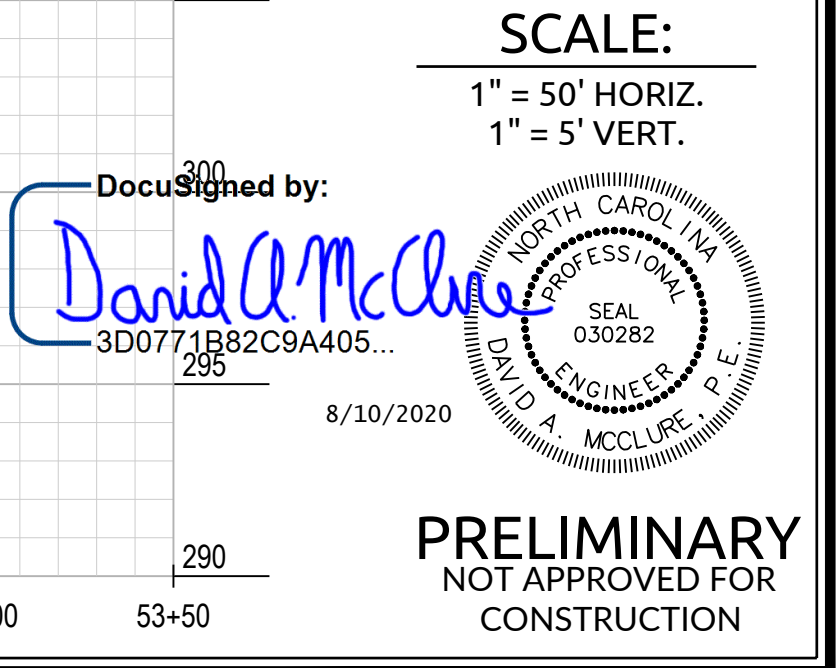
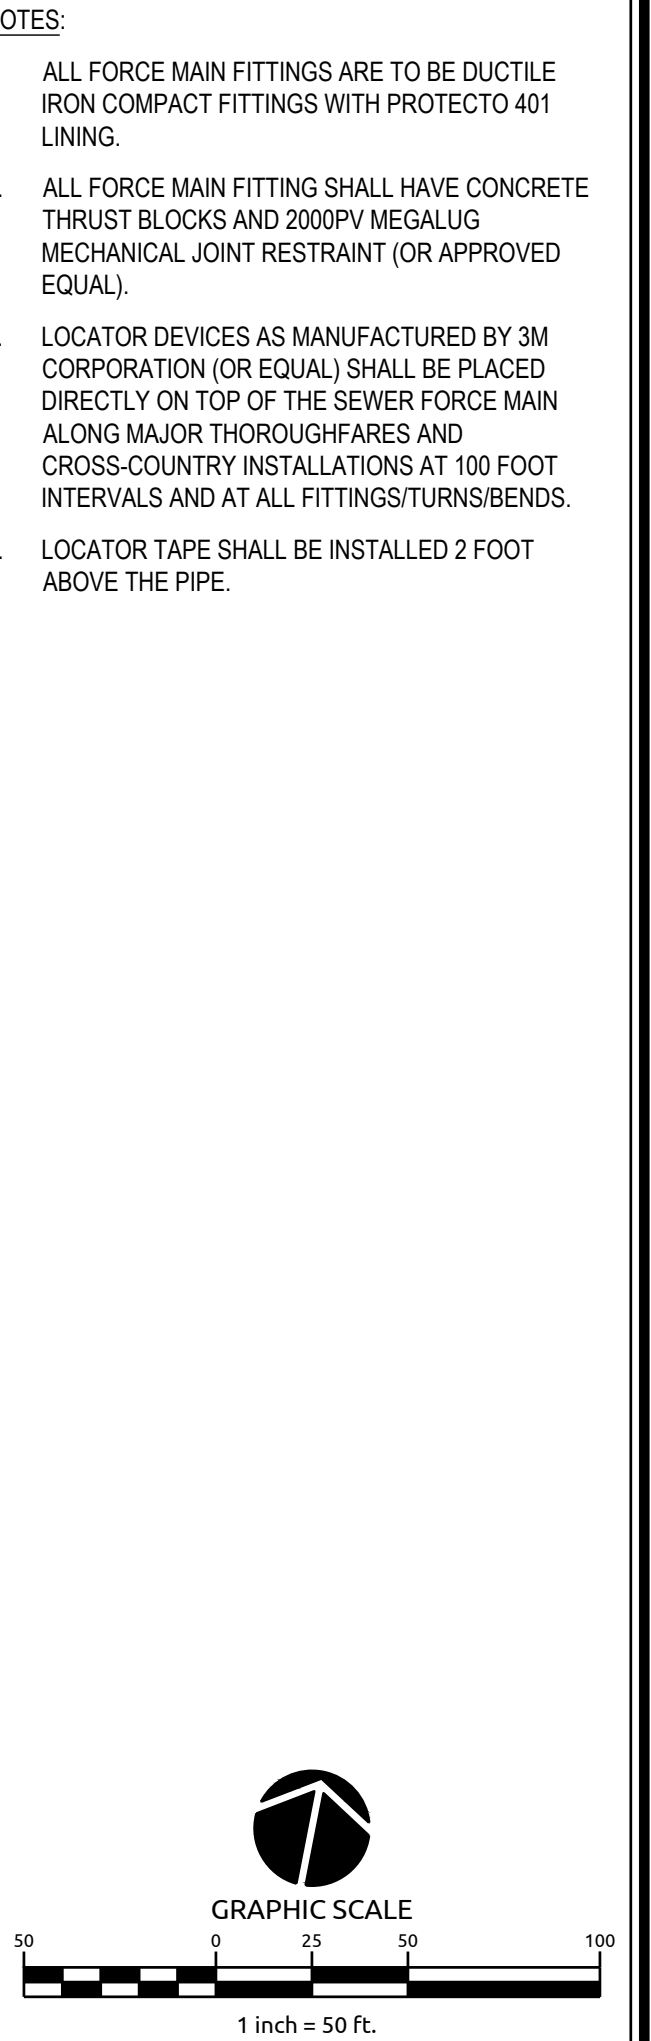


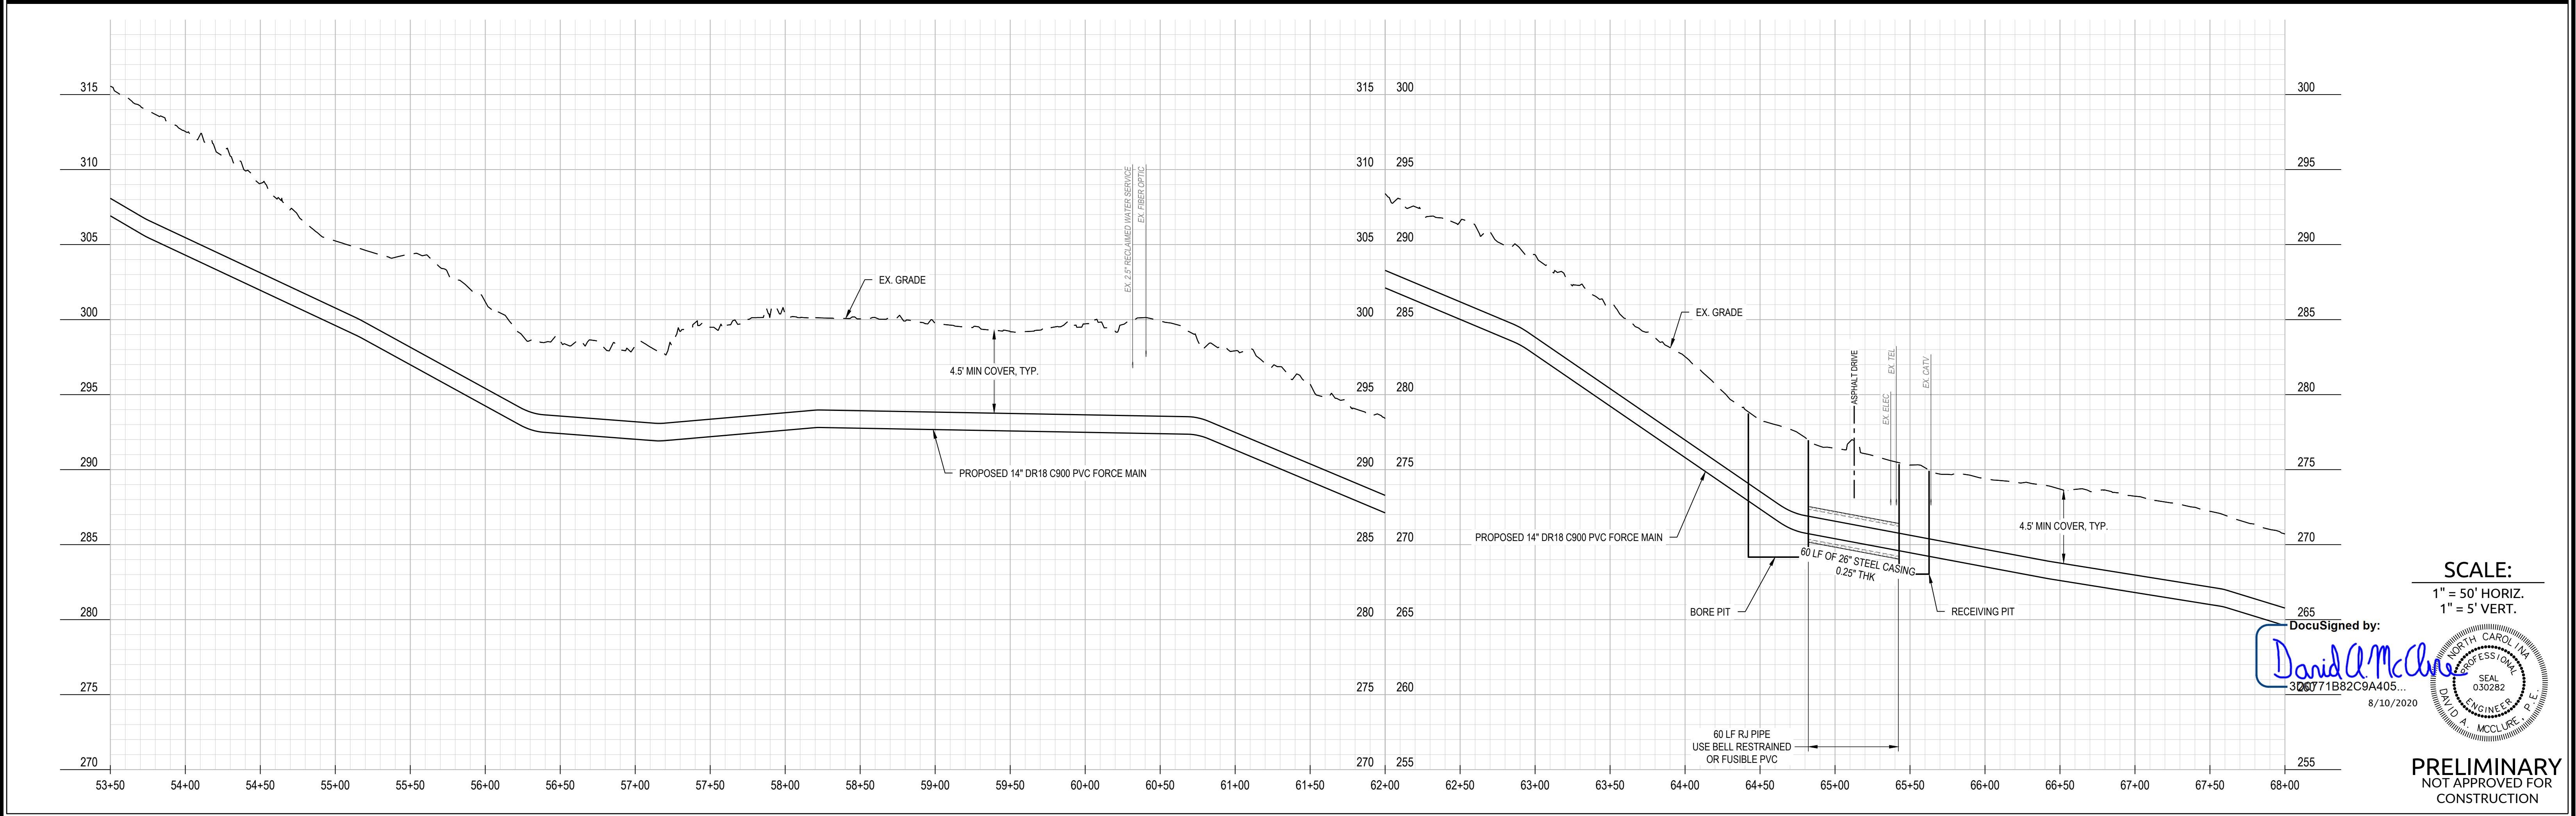

 **WithersRavenel**
Engineers | Planners | Surveyors
Drive | Cary, NC 27511 | t: 919.469.3340 | license #: C-0832 | www.withersravenel.com

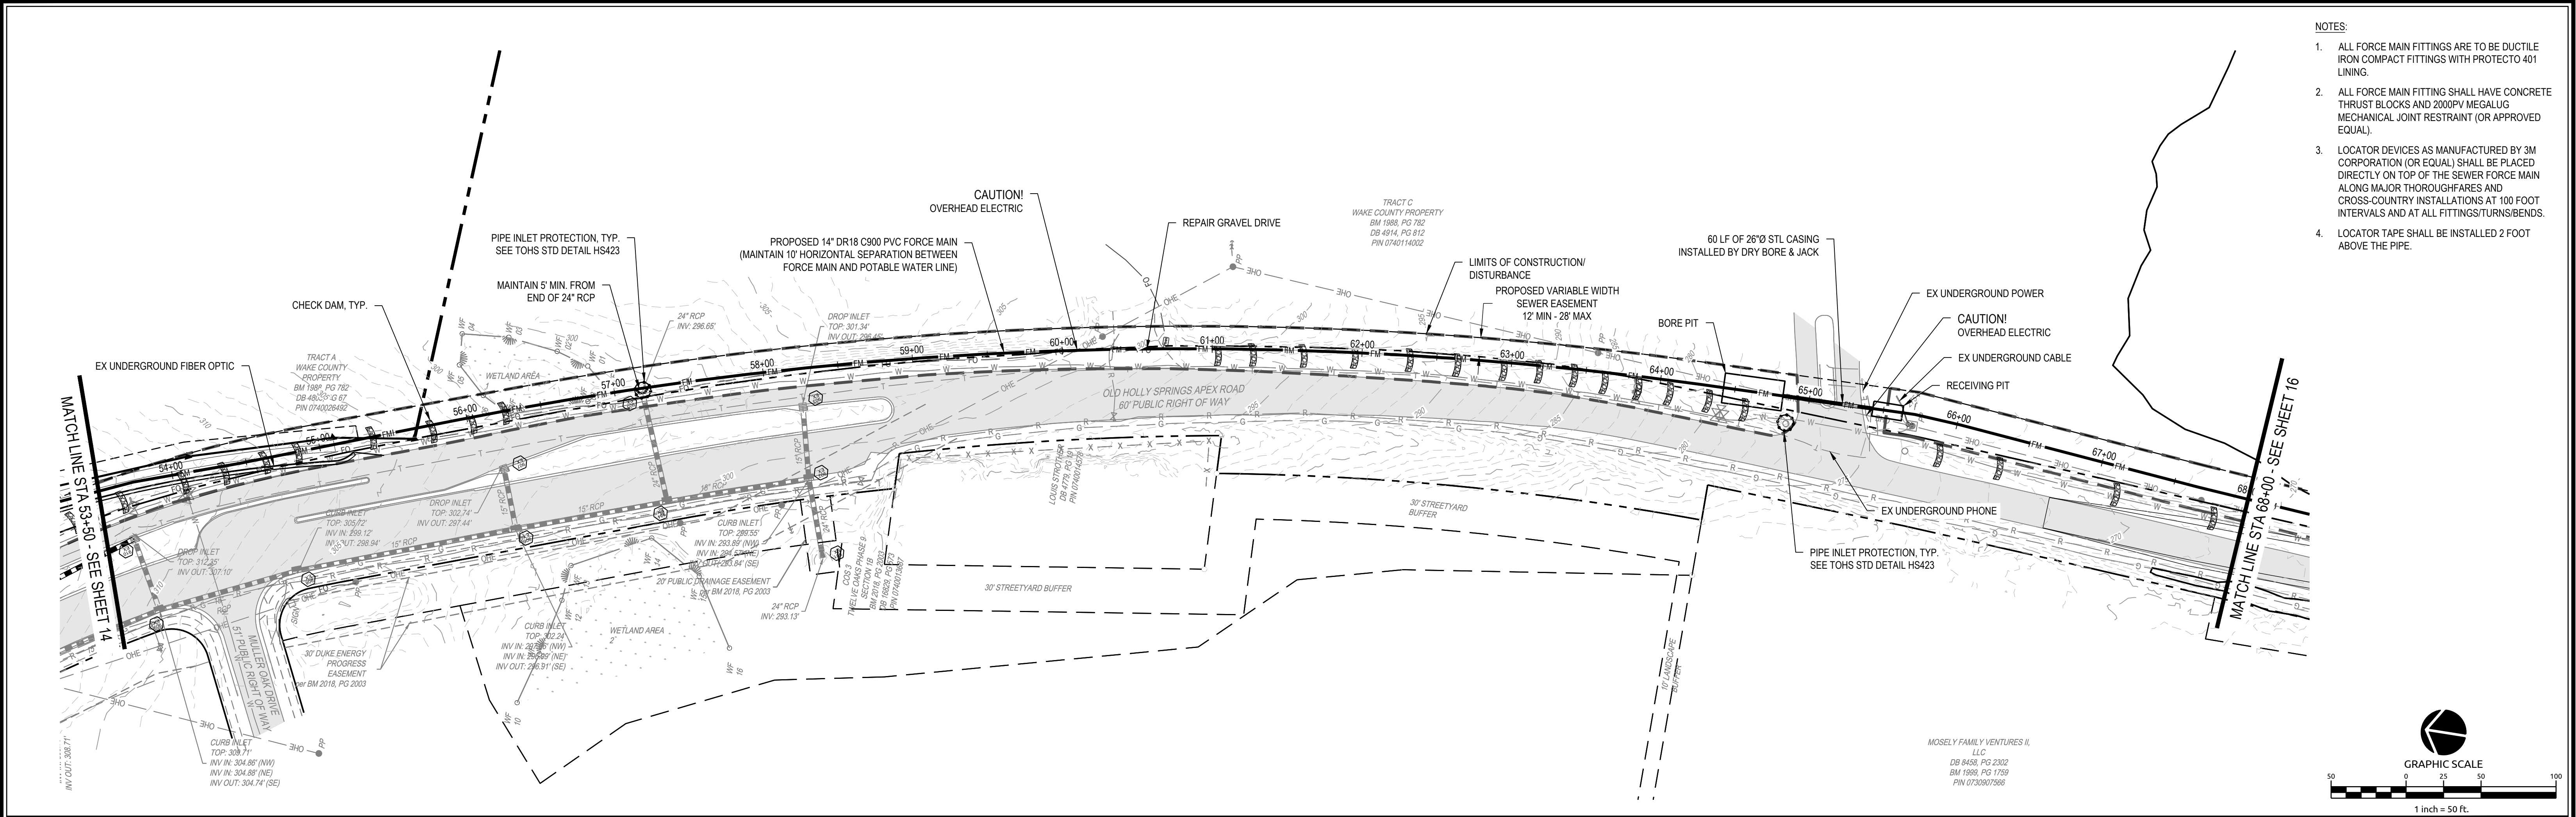

No.	Revision	Date	By

Designer	DAM	Scale	As Noted
Drawn By	PAP	Date	08.07.2020
Checked By	JWW	Job No.	02190372.10

CAROLINA SPRINGS

SEWAGE PUMP STATION #1 AND FORCE MAIN

Holly SpringsWake CountyNorth Carolina

FORCEMAIN PLAN AND PROFILE

STA 53+50 - 68+00



WithersRavenel

Engineers | Planners | Surveyors

115 MacKenan Drive | Cary, NC 27511 | t: 919.469.3340 | license #: C-0832 | www.withersravenel.com

Sheet No.

15

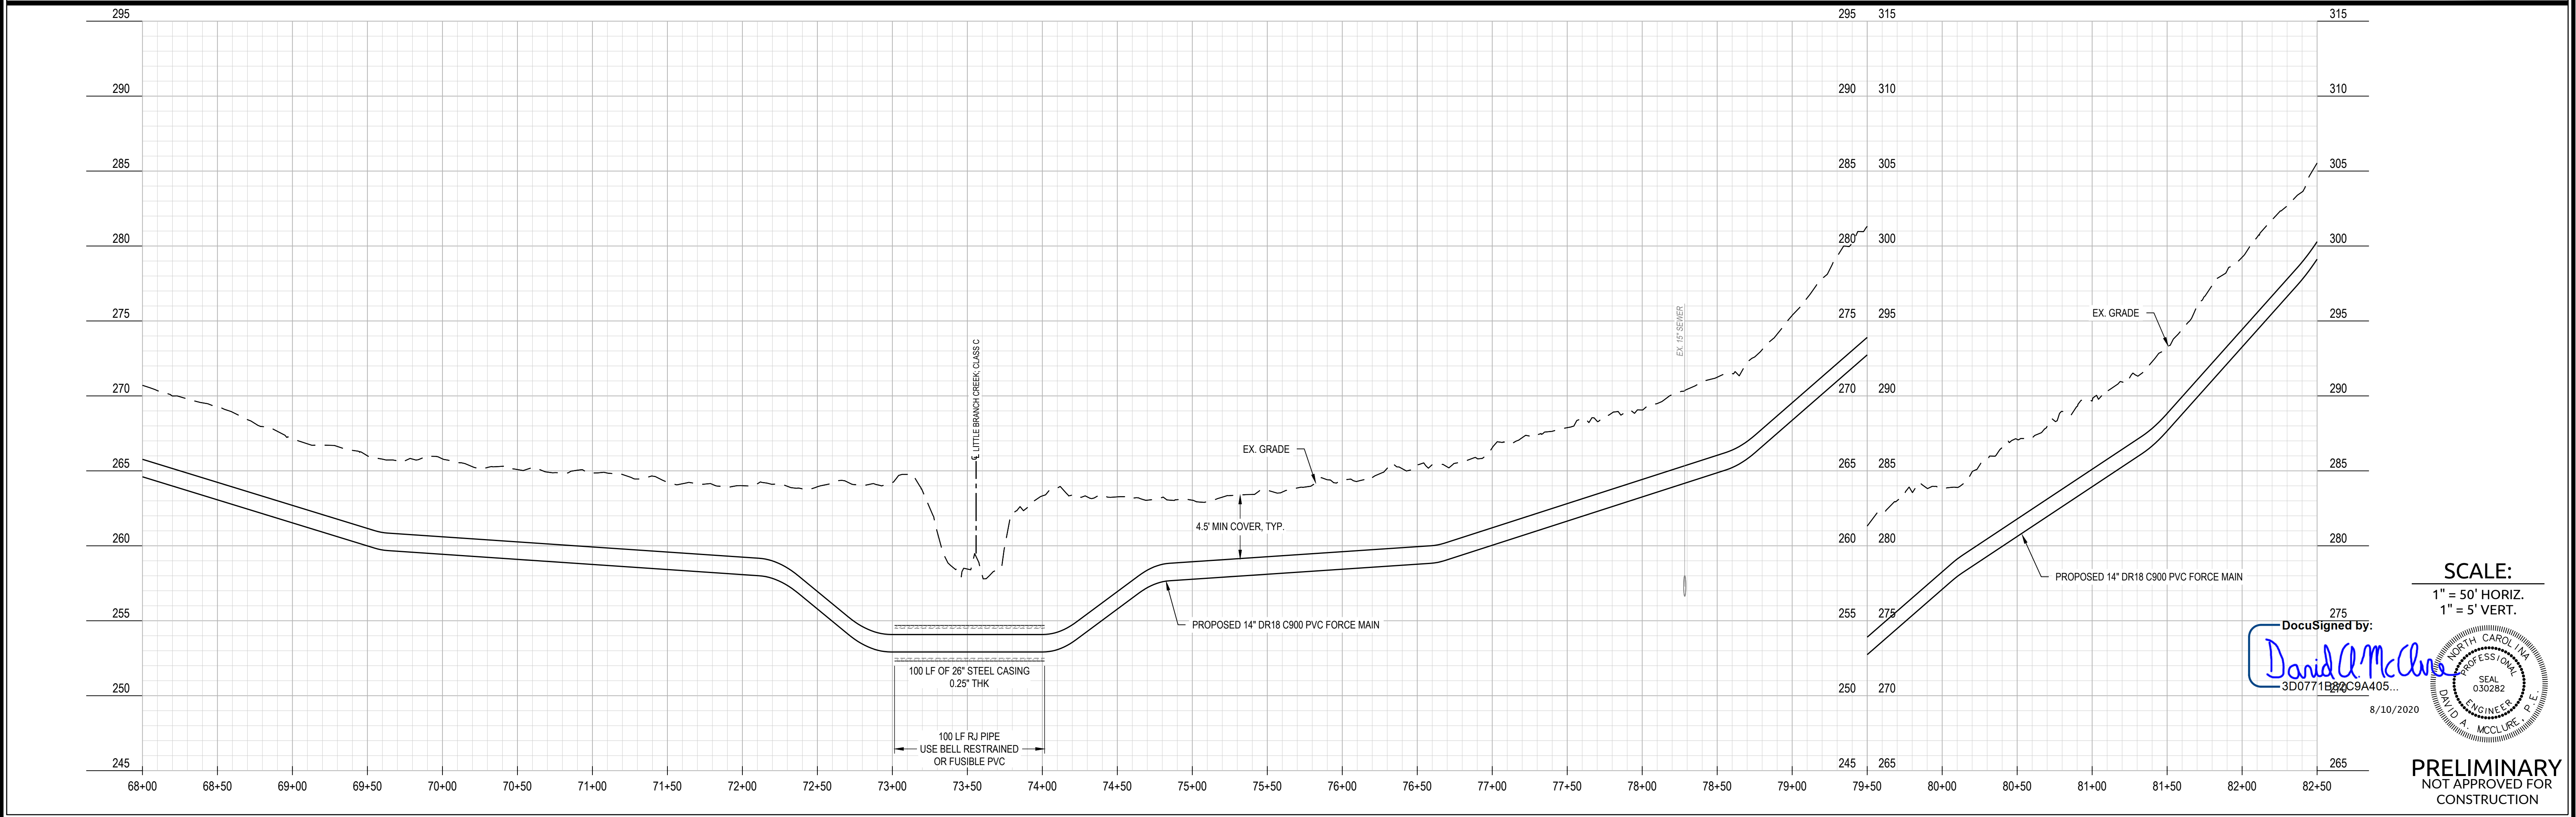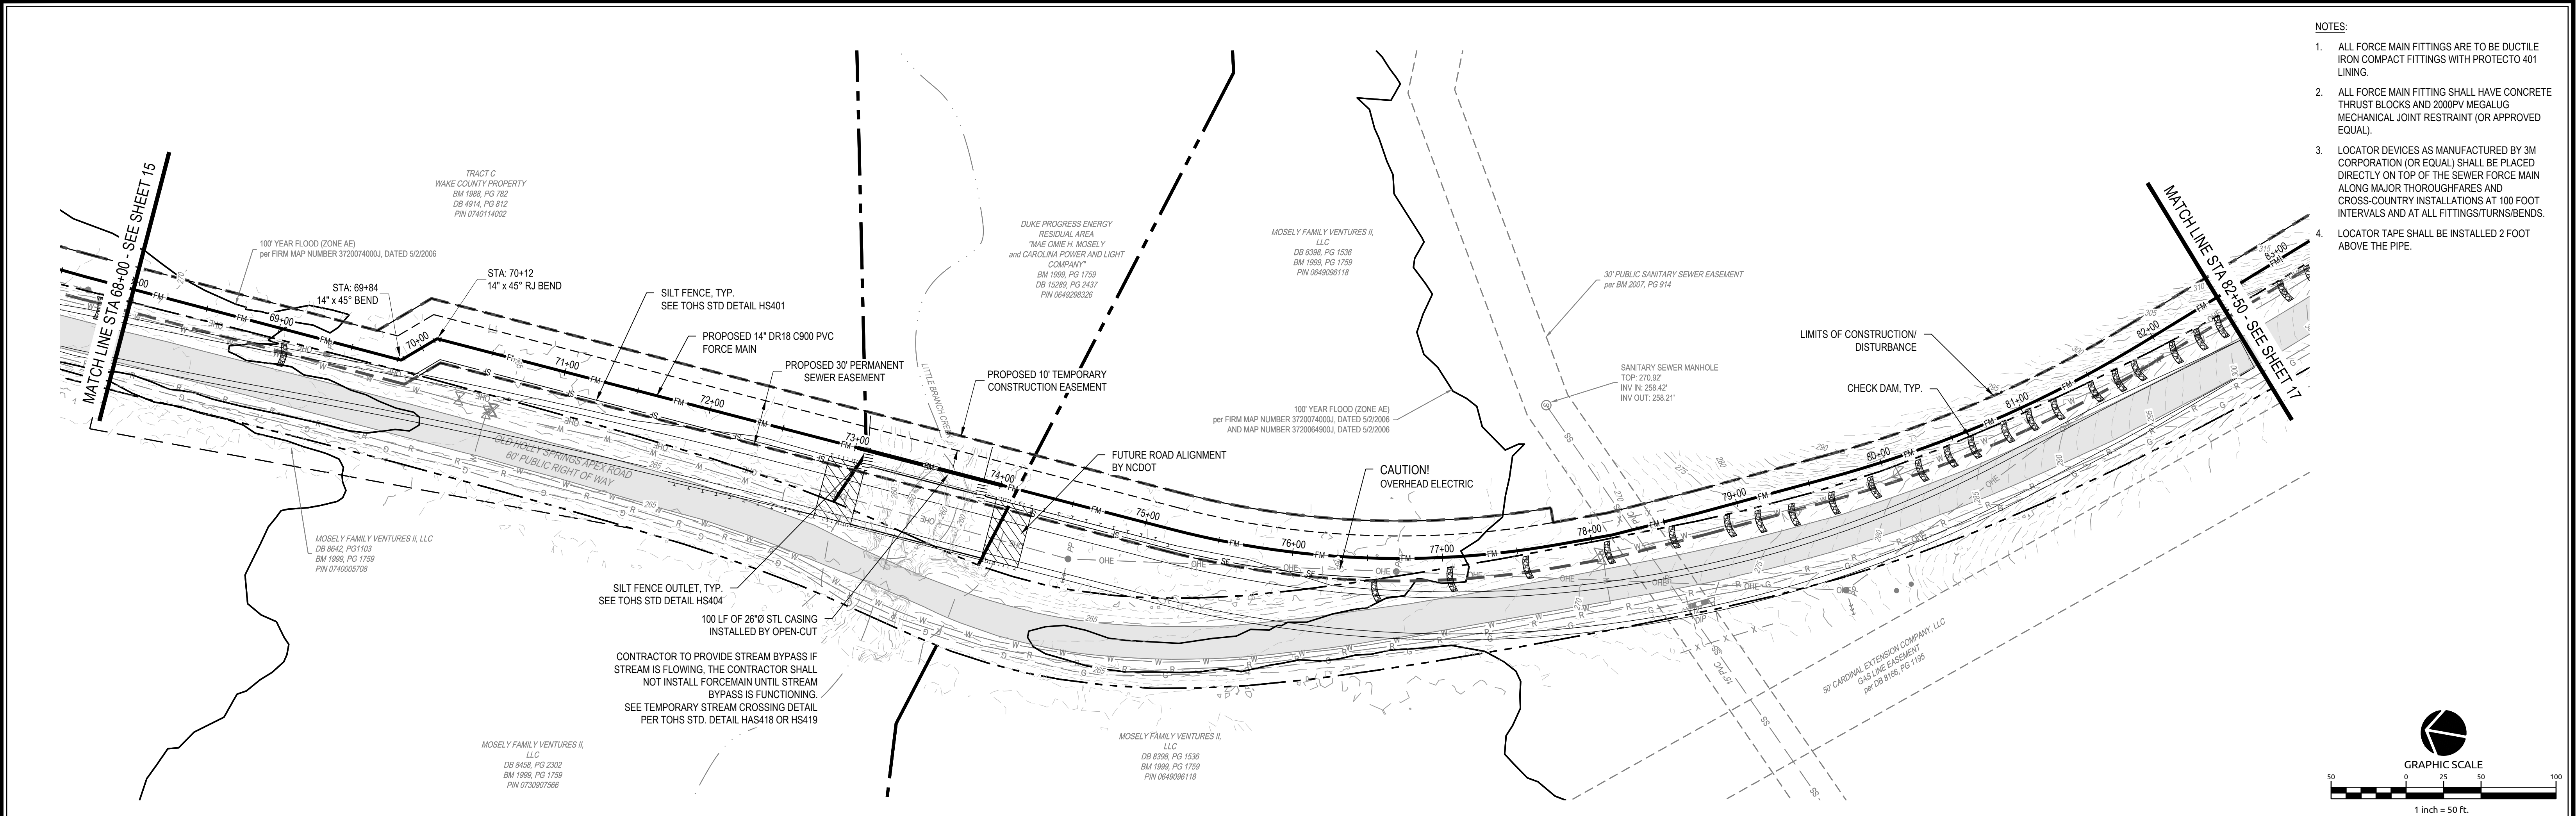

No.	Revision	Date	By

Designer	DAM	Scale	As Noted
Drawn By	PAP	Date	08.07.2020
Checked By	JWW	Job No.	02190372.10

CAROLINA SPRINGS
SEWAGE PUMP STATION #1 AND FORCE MAIN
Holly Springs Wake County North Carolina

FORCEMAIN PLAN AND PROFILE
STA 68+00 - 82+50

WithersRavenel
Engineers | Planners | Surveyors
115 MacKenan Drive | Cary, NC 27511 | t: 919.469.3340 | license #: C-0832 | www.withersravenel.com

Sheet No.
16